


Filepath: T:\61519 PNC Fed Fund Co. Callias & Associates, LLC - Georgia PHOCADDIT - Exhibit\Alternative Review Analysis

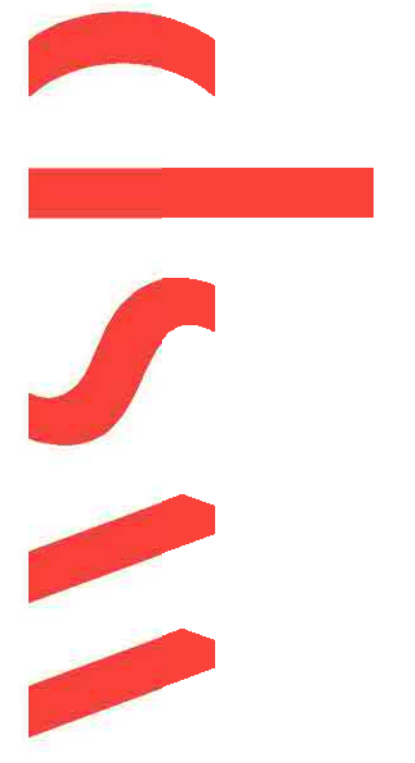

13550 Dulles Technology Drive, Ste 300, Herndon, VA, 20171 - 703-742-5700

Seal

Revisions	Date

**NEABSCO/POTOMAC
COMMUTER PARKING GARAGE**
**ALTERNATIVES ANALYSIS
CONCEPTUAL SITE PLAN**

Project Name: _____
 Designed: C. FRAGALE
 Drawn: C. FRAGALE
 Checked: R. MORRIS
 Filename: Garage_Site Plan_Site 5 ORIGINAL_03_2016
 Plotted: 11/22/2019 6:10 PM
 Plotted by: fragalec
 Scale: Hor: 1"=50'
 Vert: N/A
 Sheet 1

Prince William County, VA